

SIGN/STAMP

DATE

 
CONSULTANT

DATE

NOTE:

ALL DIMENSIONS ARE IN MM.
 DO NOT SCALE DRAWINGS.
 CONTRACTOR TO VERIFY LOCATION OF
 ALL EXISTING UTILITIES AND
 HVAC/ELECTRICAL/PLUMBING SYSTEMS.
 ANY AMBIGUITY OR DISCREPANCY
 DISCOVERED SHALL BE REPORTED
 IMMEDIATELY TO THE ARCHITECT.

SITE NORTH:



REVISION

NO.	DESCRIPTION	DATE

* APPLICABLE ON THIS SHEET

CLIENT

BASERA
 NGO

PROJECT NAME

BAbE
 BEERWAH, KASHMIR

SHEET TITLE

FLOOR PLANS

DRAWN BY:

RB

CHKD BY:

VK


DATE:

140325


SHEET NUMBER:

A-1.00


FOR COMMENTS ONLY

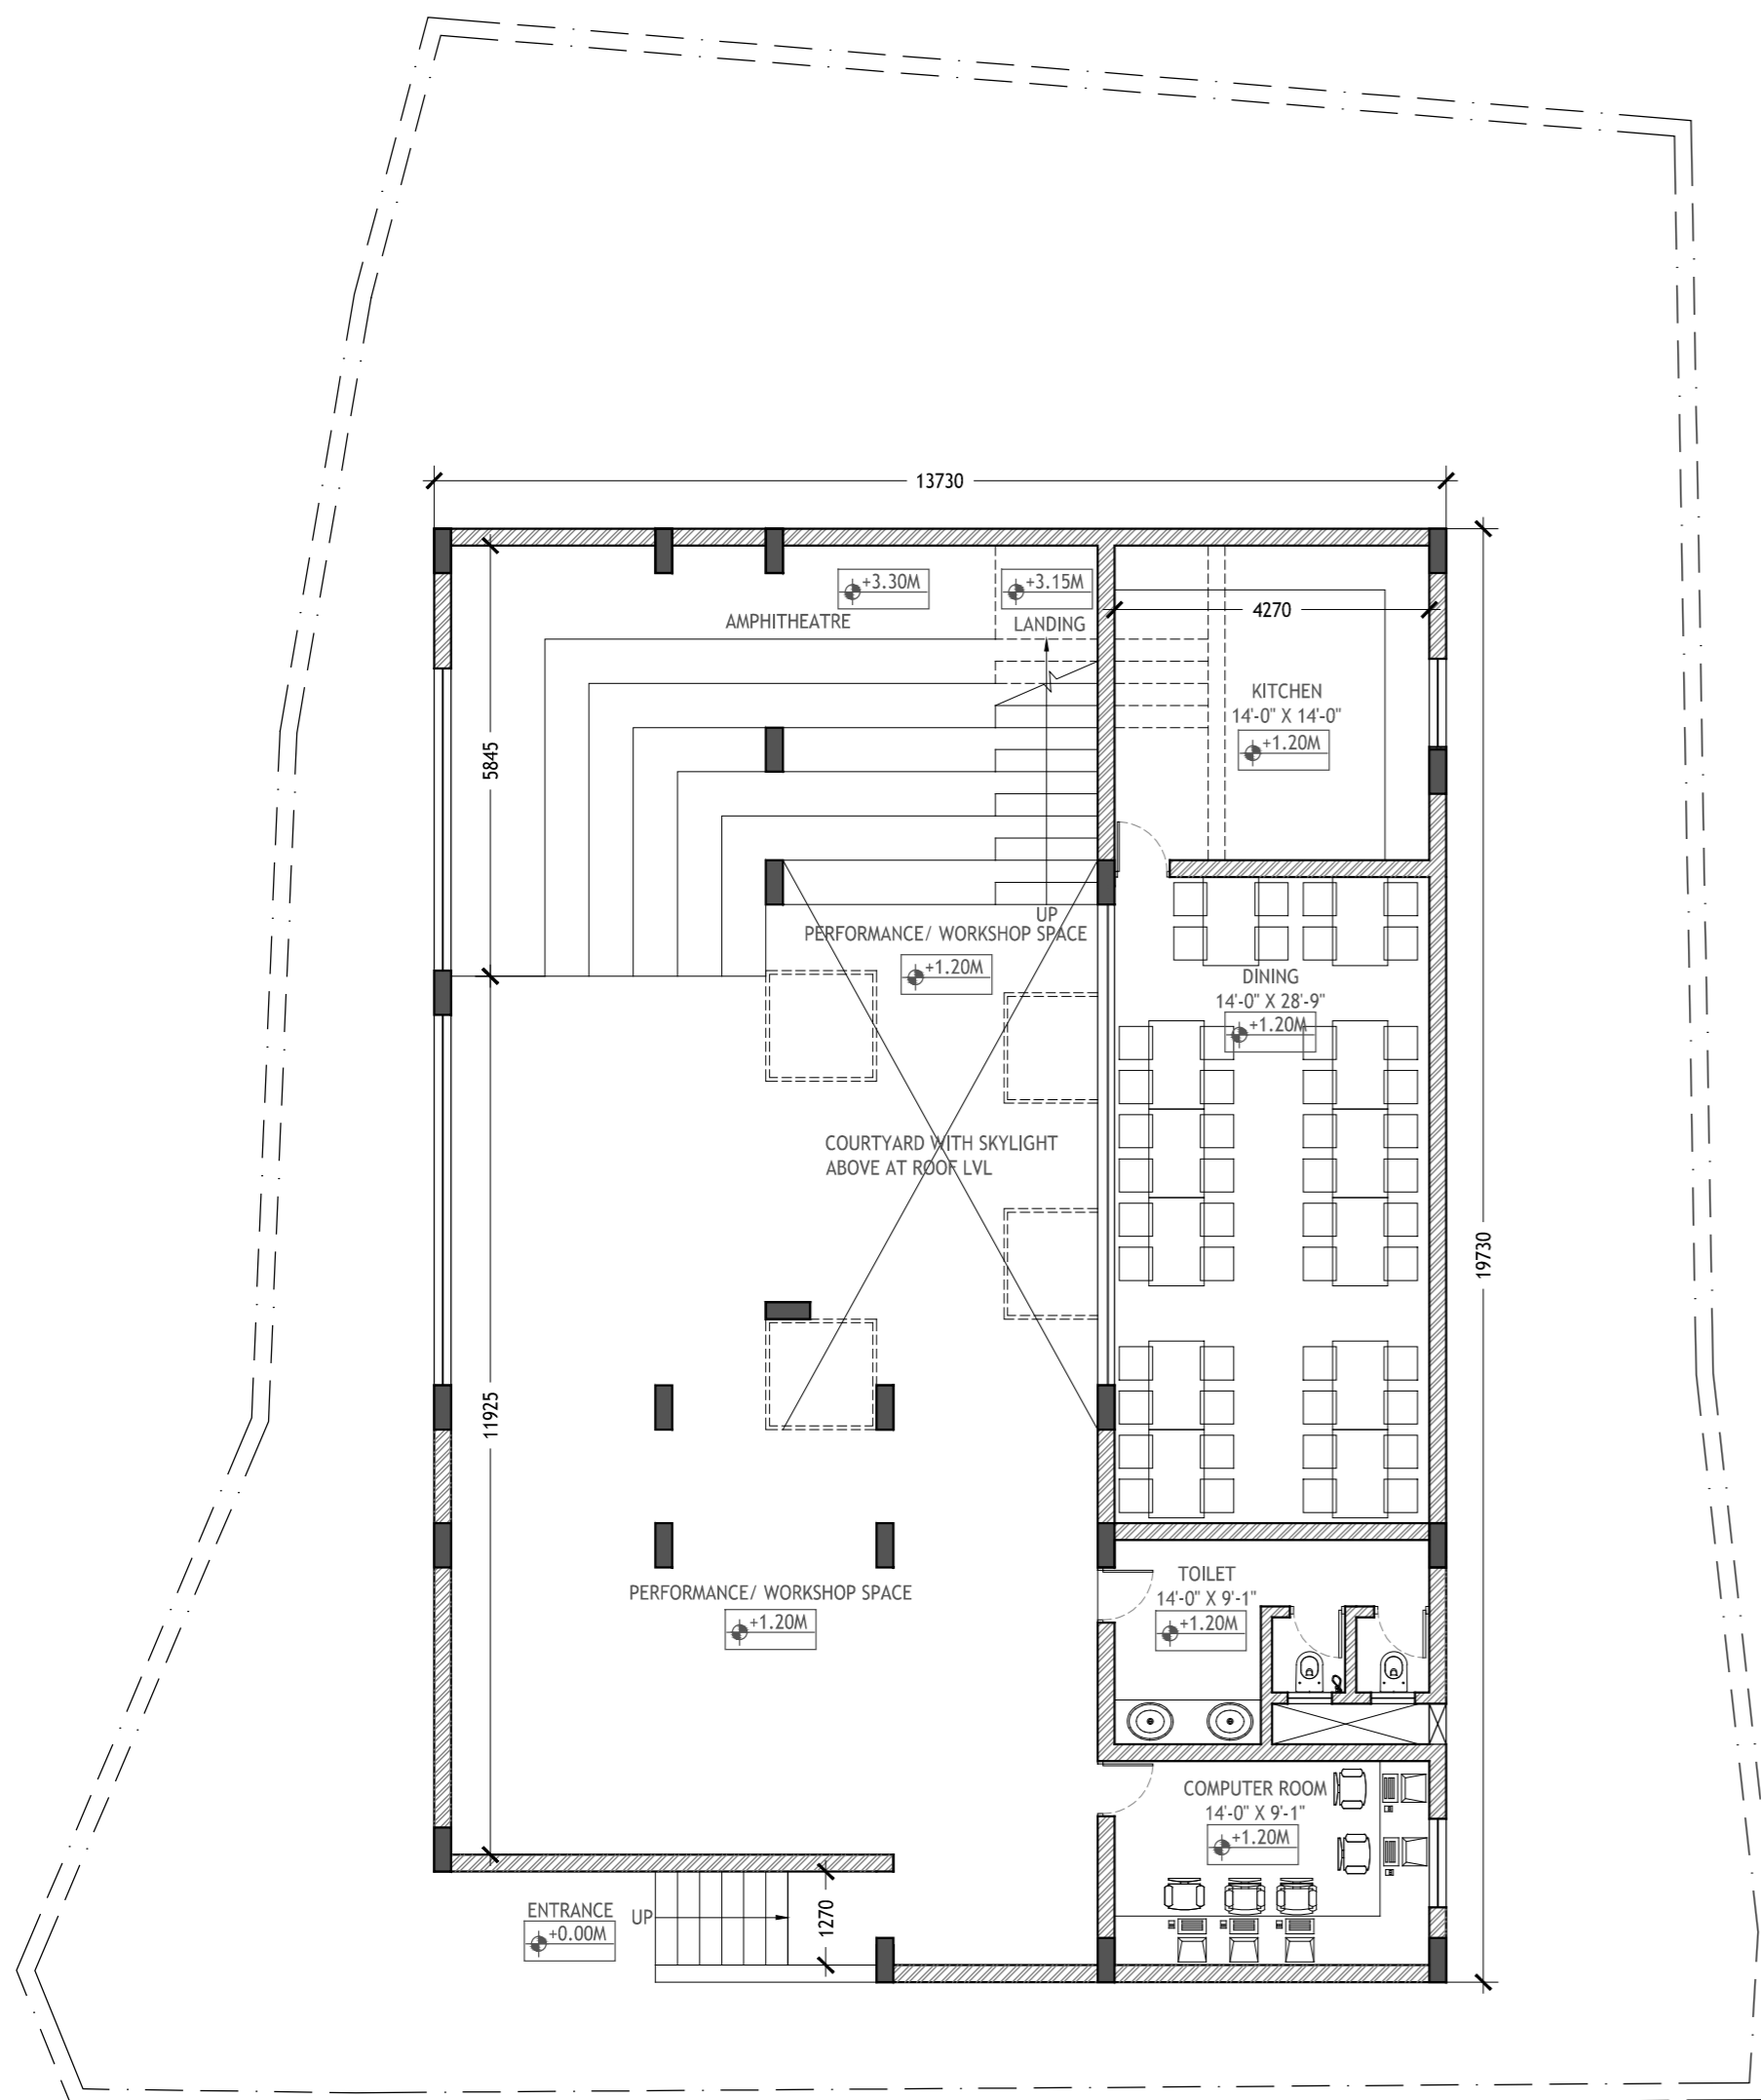

2 PLAN @ 0.00 M
 Scale: 1:100

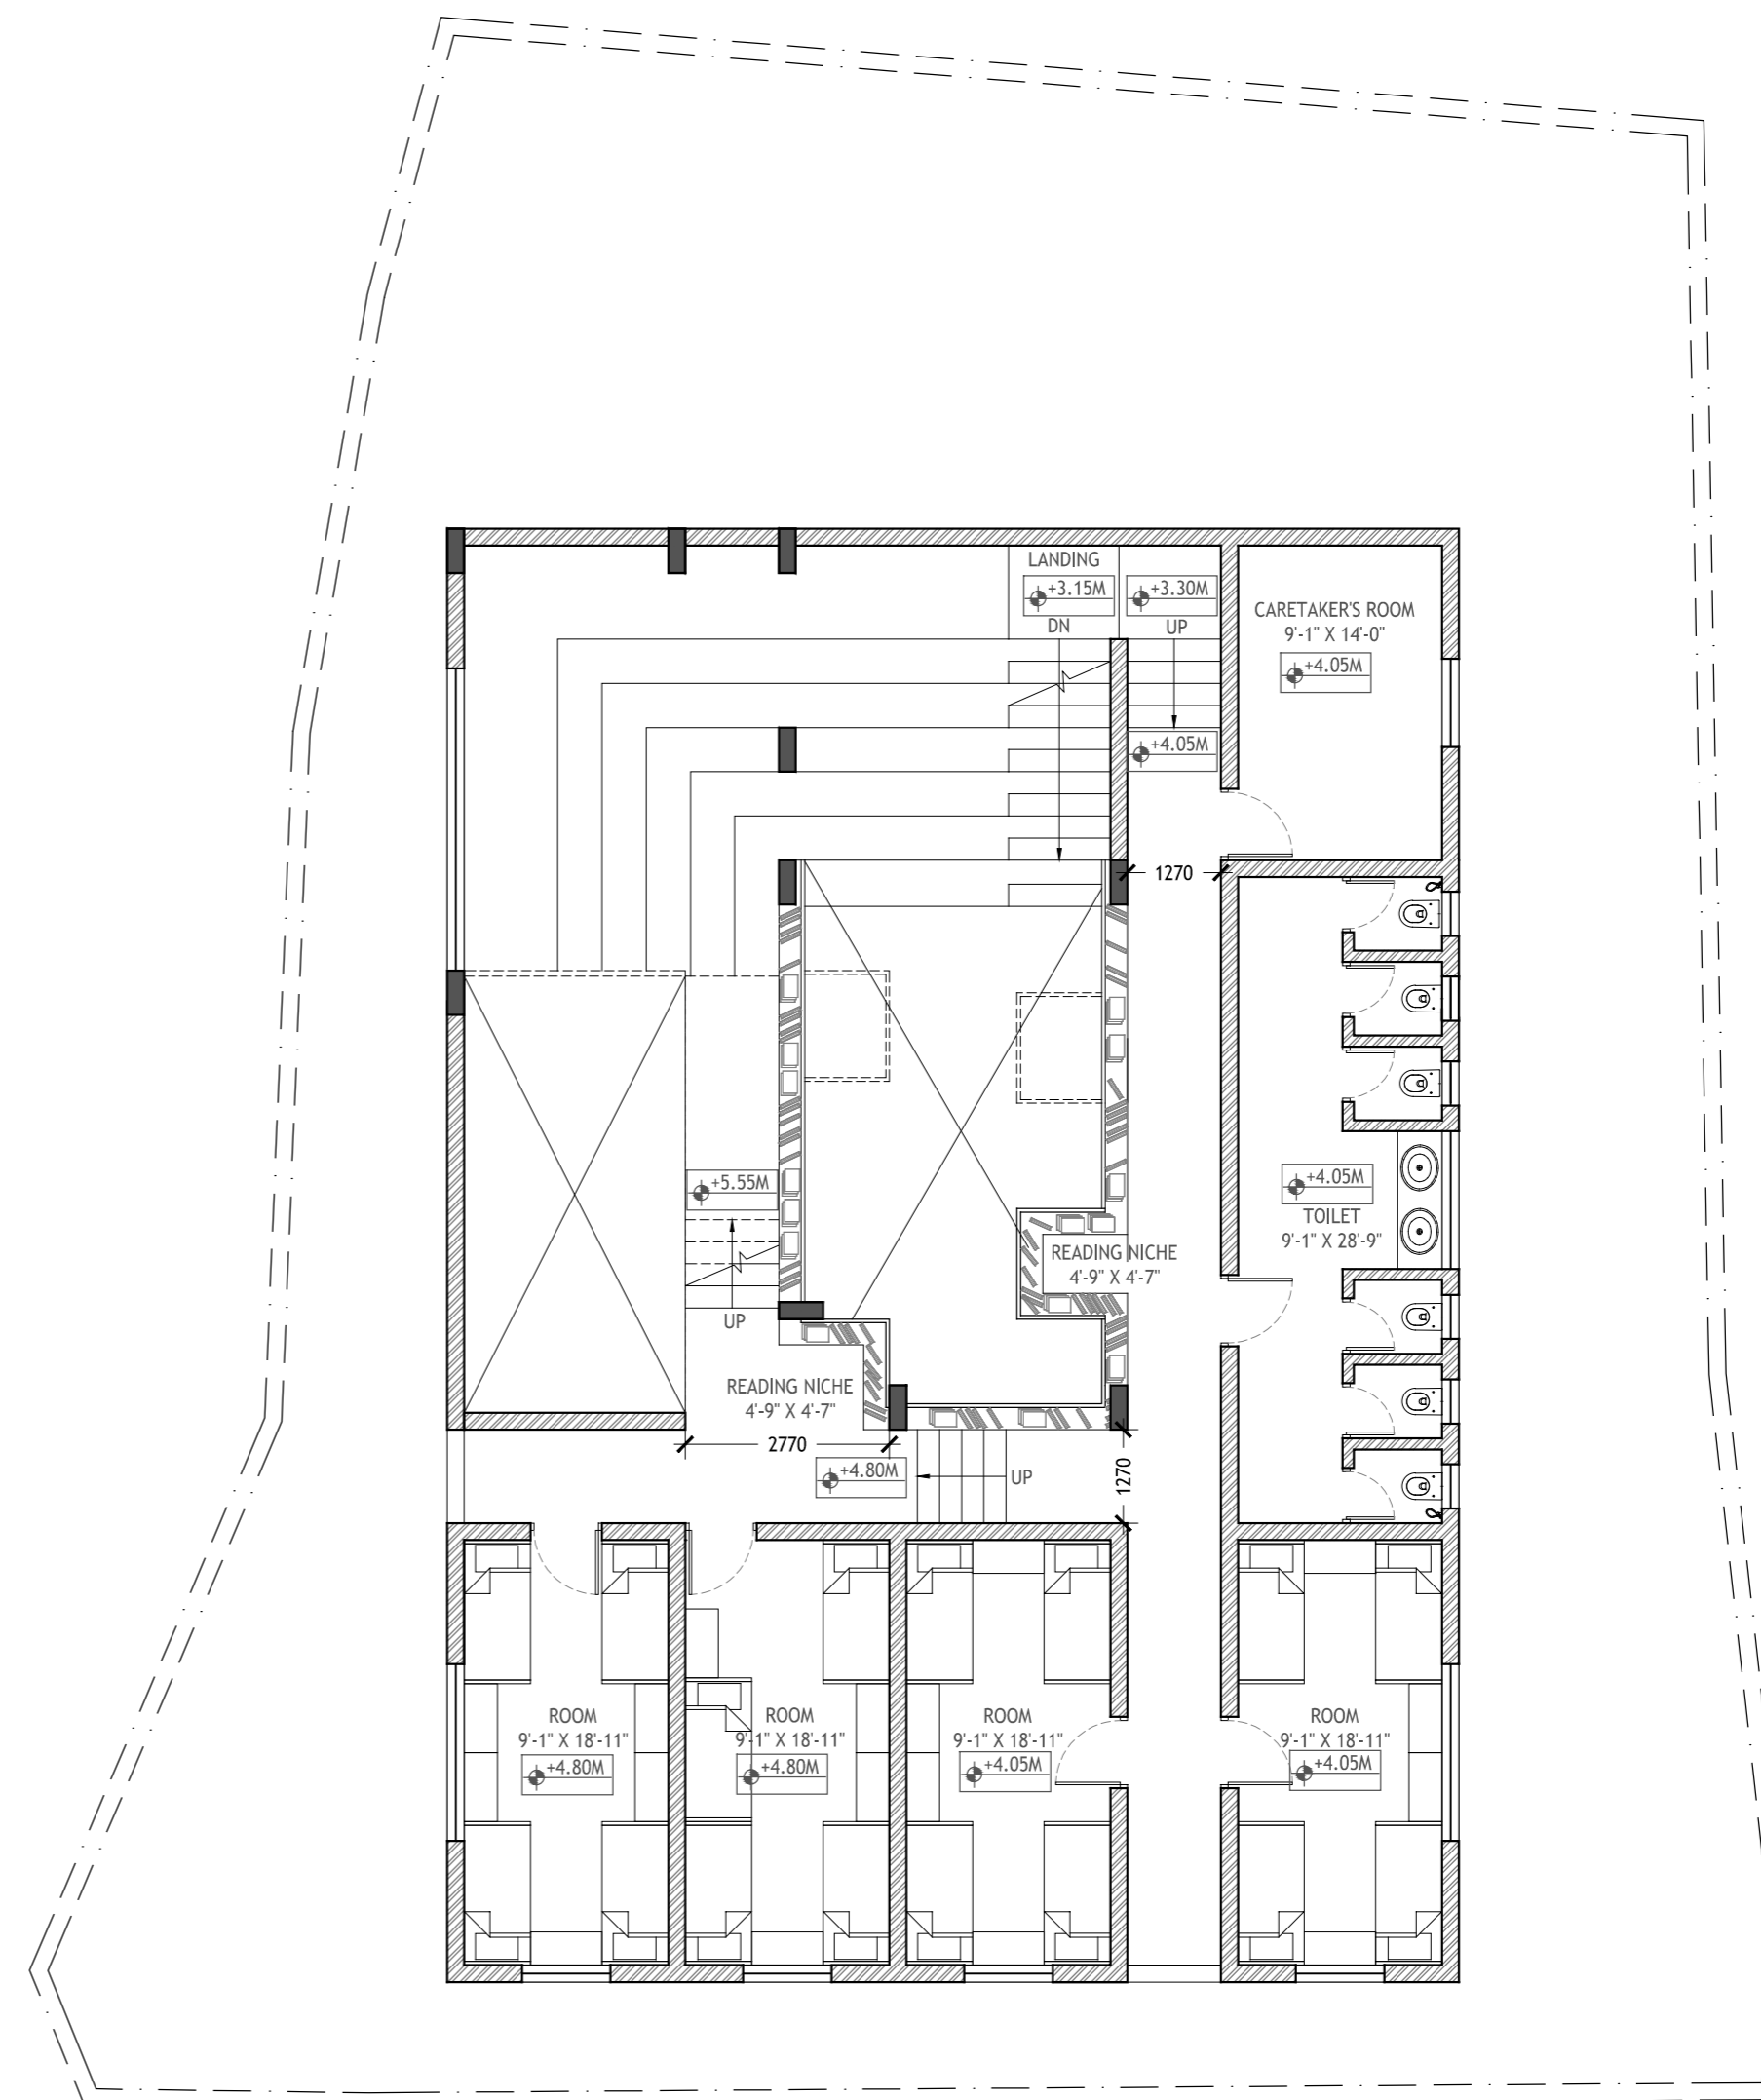

3 PLAN @ 4.80 M
 Scale: 1:100

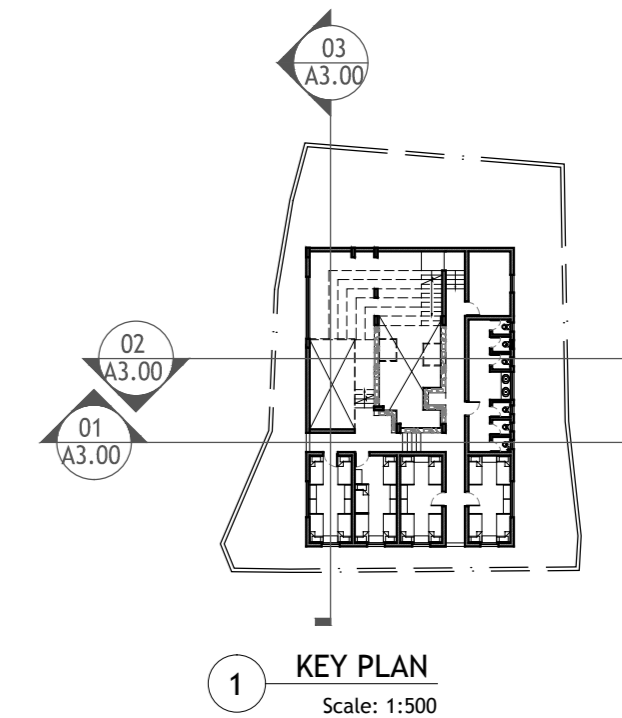

1 KEY PLAN
 Scale: 1:500