


SIGN/STAMP

DATE

CONSULTANT

DATE

NOTE:
 ALL DIMENSIONS ARE IN MM.
 DO NOT SCALE DRAWINGS.
 CONTRACTOR TO VERIFY LOCATION OF
 ALL EXISTING UTILITIES AND
 HVAC/ELECTRICAL/PLUMBING SYSTEMS.
 ANY AMBIGUITY OR DISCREPANCY
 DISCOVERED SHALL BE REPORTED
 IMMEDIATELY TO THE ARCHITECT.

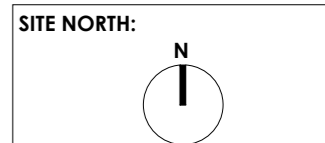

REVISION		
NO.	DESCRIPTION	DATE

* APPLICABLE ON THIS SHEET

CLIENT
**BASERA
 NGO**

PROJECT NAME
**BAbE
 BEERWAH, KASHMIR**

SHEET TITLE
FLOOR PLANS

DRAWN BY: RB


CHKD BY: VK

DATE: 140325


SHEET NUMBER:

A-1.01


FOR COMMENTS ONLY

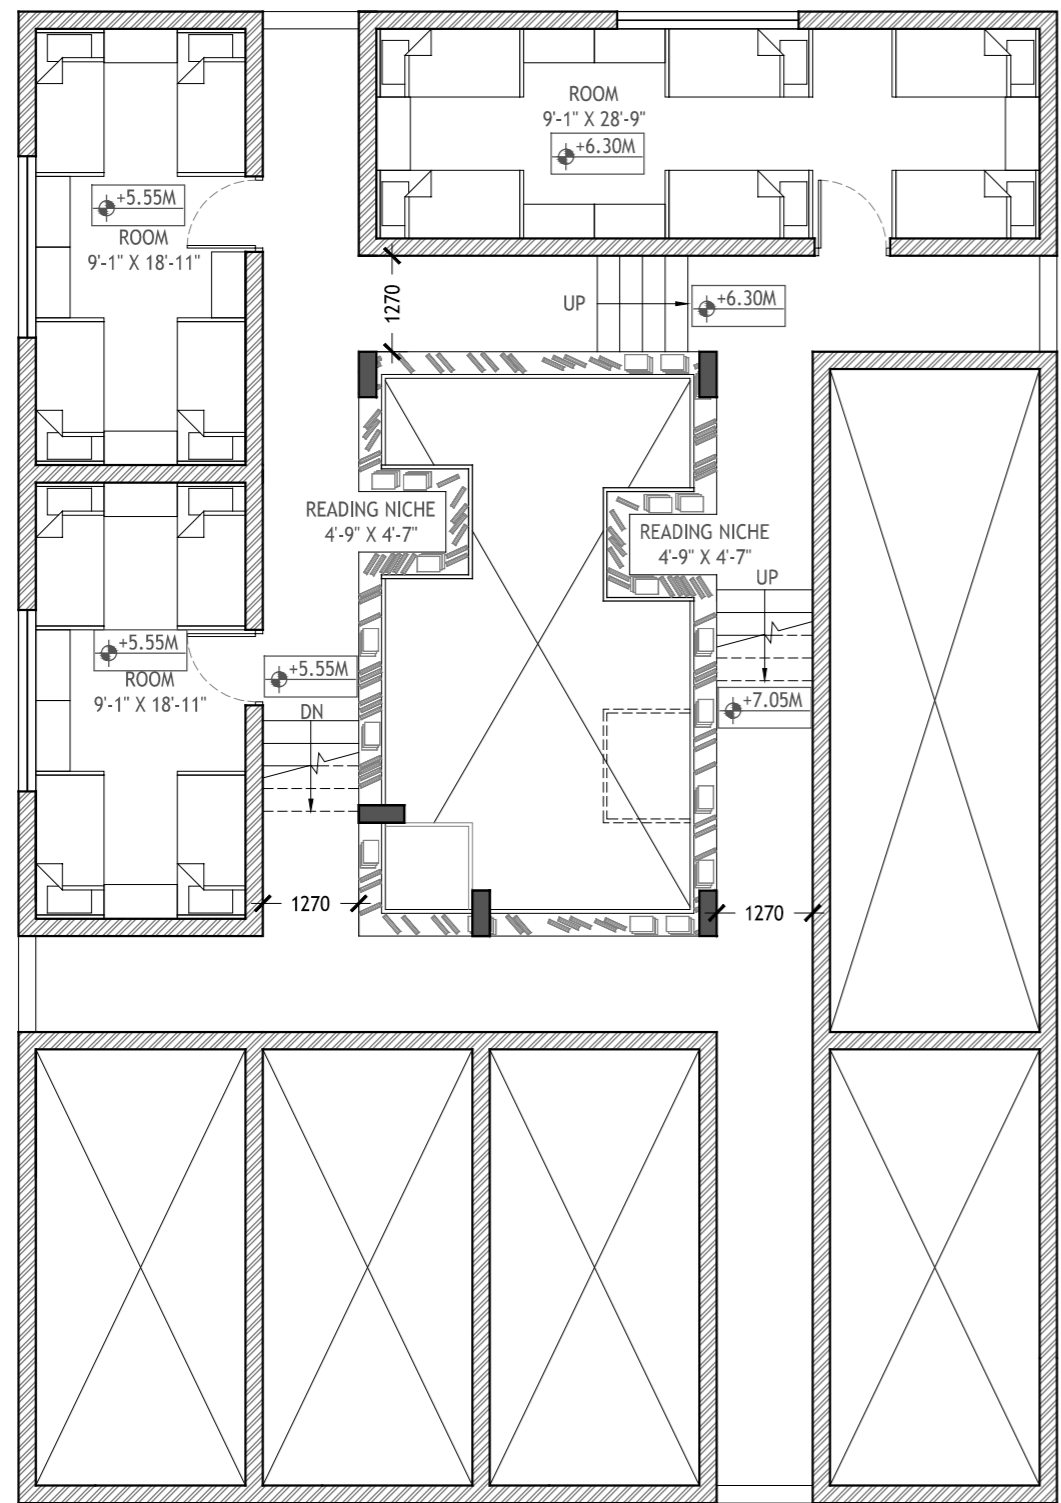

2 PLAN @ 6.30 M
 Scale: 1:100

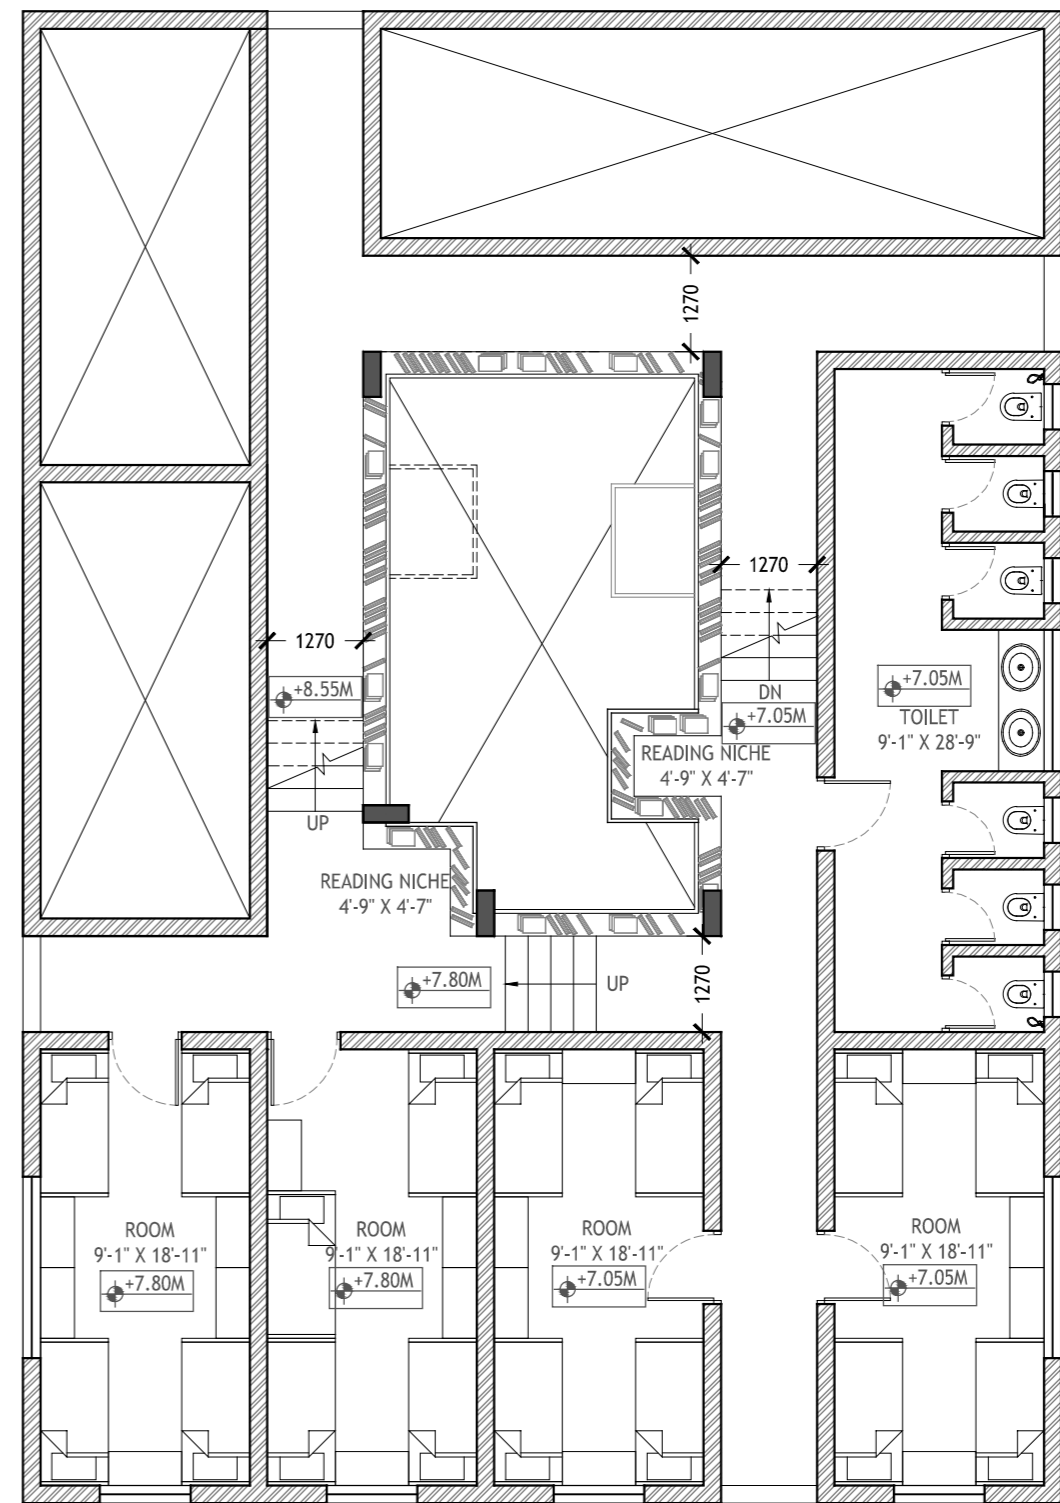

3 PLAN @ 7.80 M
 Scale: 1:100

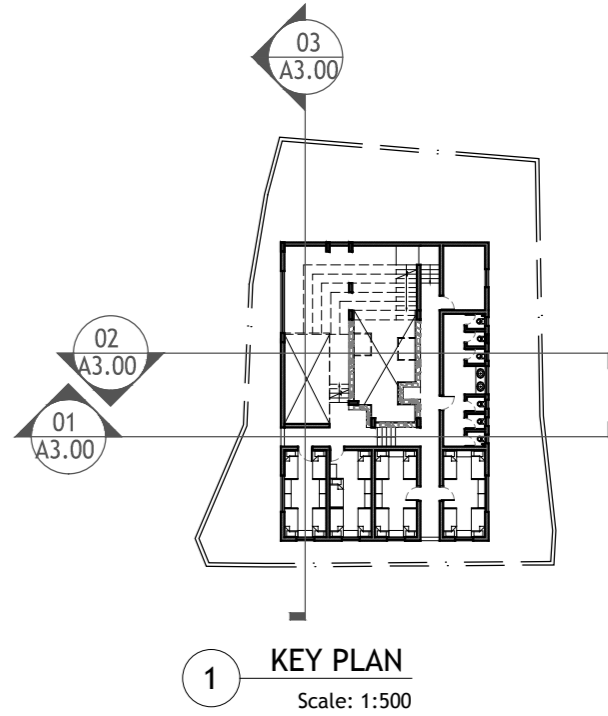

1 KEY PLAN
 Scale: 1:500